



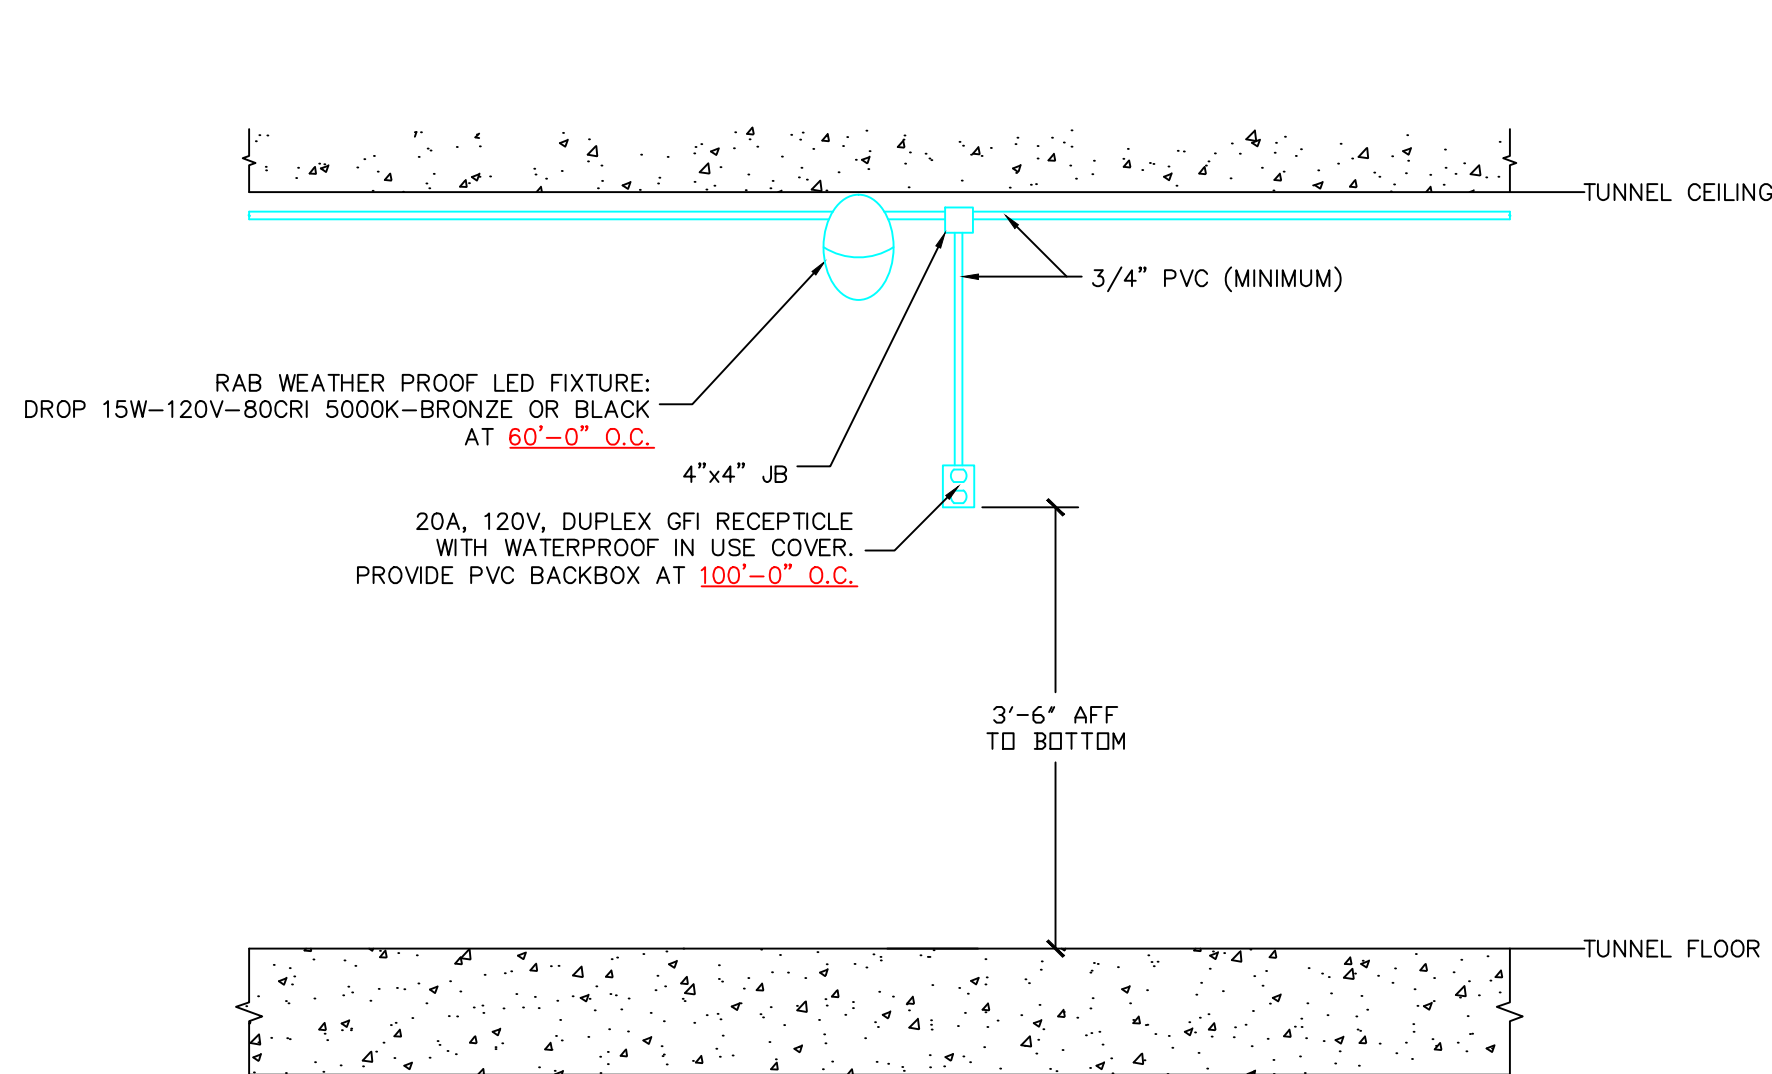

1 TUNNEL LIGHTING DETAIL
G-1 SCALE: NTS

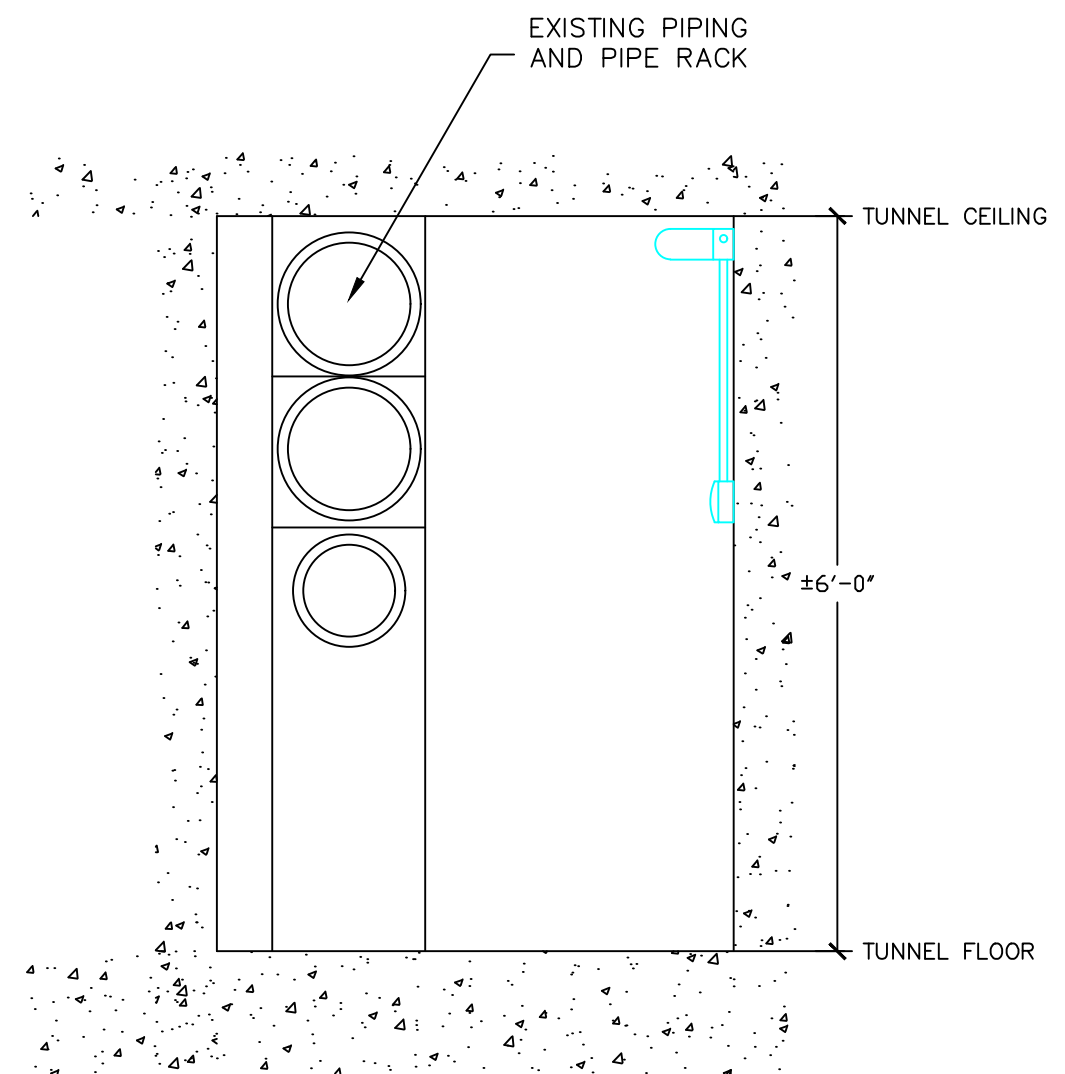

2 TUNNEL LOCATION REFERENCE
G-1 SCALE: NTS

LANT ENGINEERING
& PLANNING OFFICE
FACILITIES MANAGEMENT
& COMBINED SERVICES BUILDING
MOUNT PLEASANT, MI 48859
OFFICE: (989)774-8559
FAX: (989)774-6187

**UNIVERSITY OF MICHIGAN
TUNNEL-LIGHTING
LIGHTING
DETAIL**

DRAWING SET INFO

```

% SCHEMATIC DESIGN REVIEW
% DATED %$CD%_ISSUE_DATE
%
% SCHEMATIC DESIGN REVIEW
% DATED %$CD%_ISSUE_DATE
%
% DESIGN DEVELOPMENT REVIEW
% DATED %$CD%_ISSUE_DATE
%
% DESIGN DEVELOPMENT REVIEW
% DATED %$CD%_ISSUE_DATE
%
% CONSTRUCTION DOC. REVIEW
% DATED %$CD%_ISSUE_DATE
%
% CONSTRUCTION DOC. REVIEW
% DATED %$CD%_ISSUE_DATE
%
% AND CONSTRUCTION SET
% DATED %$D%_ISSUE_DATE
%
% AL RECORD -- AS BUILT SET
% DATED RECORD_ISSUE_DATE
%
% REFERENCE ONLY
% DATED REF_ISSUE_DATE
%
% SITE PLAN REVIEW
% DATED STATEMENT_REV_ISSUE_DATE
%

```

**ADDENDUM/BULLETIN
REVISIONS**

[illegible]

SALE	NTS
------	-----

DRAWN BY _____

CHECKED BY _____
APPROVED BY _____

SHEET NO.

PROJECT NO.

NU PROJECT NO.